


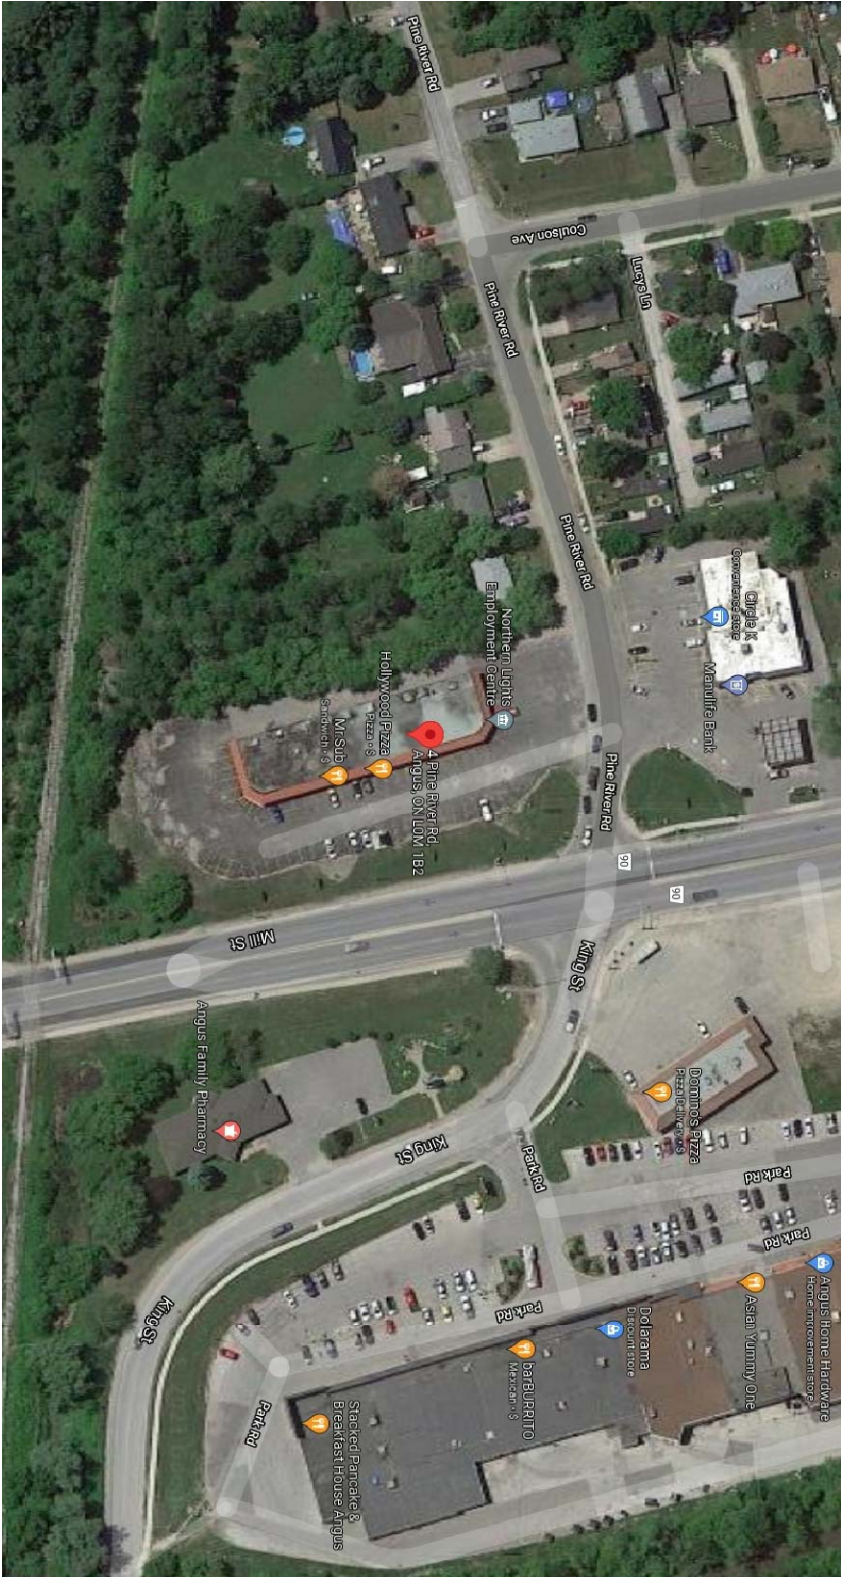

SITE LOCATION

ONTARIO BUILDING CODE DATA MATRIX					
ONTARIO BUILDING CODE DATA MATRIX PARTS 3 & 9					
ITEM	OBC Reference				
	☐ New	☐ Part 1	☐ Part 3	☐ Part 9	
1	PROJECT DESCRIPTION: INTERIOR ALTERATION OF EXISTING GROUP 'E' UNIT TO BIRYANI BAR RESTAURANT "GROUP E"				
	☐ Addition	☒ Alteration	☐ Change of use		
2.1	MAJOR OCCUPANCY: GROUP 'E'				
2.2	OCCUPANCY OF SUITE COVERED UNDER THIS PERMIT: 'E' (RETAIL)				
4	AREA OF SUITE COVERED UNDER THIS PERMIT APPLICATION (m ²): 142.5				
5	NUMBER OF STOREYS ABOVE GRADE: 1 BELOW GRADE: 0				
6	HEIGHT OF BUILDING (m) ABOVE GRADE: 0 BELOW GRADE: 0				
7	NUMBER OF STREETS/ACCESS ROUTES: 2				
8	BUILDING CLASSIFICATION (GROUP 'E'):				
9	SPRINKLER SYSTEM ☐ Existing ☐ Entire building ☐ Proposed ☐ Basement only ☐ Not required ☐ In lieu of roof rating				
10	STANDPIPE SYSTEM REQUIRED ☐ Yes ☐ No				
11	FIRE ALARM SYSTEM REQUIRED ☐ Yes ☐ No ☐ Existing				
12	WATER SERVICE SUPPLY IS ADEQUATE ☒ Yes ☐ No				
13	HIGH BUILDING ☐ Yes ☒ No				
14	PERMITTED CONSTRUCTION ☐ Combustible ☐ Non-Combustible ☐ Both ACTUAL CONSTRUCTION ☐ Combustible ☐ Non-Combustible ☐ Both				
15	MEZZANINE AREA WITHIN SUITE (m ²): N/A				
16	OCCUPANT LOAD BASED ON ☐ m ² /person ☒ design of suite				
17	TOTAL OCCUPANT LOAD = 30 (28 SEATING AND 2 EMPLOYEES)				
17	BARRIER-FREE DESIGN ☐ Yes ☒ No Existing space to develop ASB				
18	HAZARDOUS SUBSTANCES ☐ Yes ☐ No				
19	REQUIRED FIRE RESISTANCE RATING				
	N/A EXISTING STRUCTURE				
20	SPATIAL SEPARATION - CONSTRUCTION OF EXTERIOR WALLS N/A EXISTING STRUCTURE				
21	EXIT CAPACITY ONE FRONT EGRESS DOOR IS PROVIDED (EXISTING). ONE REAR EGRESS DOOR IS PROVIDED (EXISTING).				
22	SANITARY FACILITIES 2 WCS PER EACH SEX + 1 EMPLOYEE WASHROOM TO REMAIN AS EXISTING				

THE UNDERSIGNED HAS REVIEWED AND TAKES RESPONSIBILITY FOR THIS DESIGN AND HAS THE QUALIFICATION AND MEETS THE REQUIREMENTS OF THE ONTARIO BUILDING CODE TO DESIGN THE WORK SHOWN ON THE ATTACHED DOCUMENTS.

QUALIFICATION INFORMATION

REQUIRED UNLESS DESIGN IS EXEMPT UNDER DIV. C-3.2.3.1 OF THE BUILDING CODE

DEVIENDRA KULKARNI

106267

NAME

SIGNATURE

BCIN

REGISTRATION INFORMATION

REQUIRED UNLESS DESIGN IS EXEMPT UNDER DIV. C-3.2.4.1 OF THE BUILDING CODE

KINESIS DESIGN INC.

121627

FIRM NAME

SIGNATURE

BCIN

IT IS THE RESPONSIBILITY OF THE APPROPRIATE CONTRACTOR TO CHECK AND VERIFY ALL DIMENSIONS ON SITE AND REPORT ALL ERRORS AND OR OMISSIONS TO THE DESIGNERS.

ALL CONTRACTORS MUST COMPLY WITH ALL PERTINENT ONTARIO BUILDING CODES AND BY-LAWS.

DO NOT SCALE DRAWINGS.

THIS DRAWING MAY NOT BE USED FOR CONSTRUCTION UNTIL SIGNED.

COPYRIGHT RESERVED.

No

Date

Revision



KINESIS DESIGN INC

ARCHITECTURE, INTERIORS

45-2 CLAY BRICK COURT,

BRAMPTON, ON. L6V 4M7

647.880.5654

kinesisdesigninc@gmail.com

PROJECT NORTH



PROJECT

BIRYANI BAR RESTAURANT

4 PINE RIVER RD, ANGUS, ON. L0M1B2

DRAWING TITLE

SITE LOCATION AND OBC MATRIX

SCALE

3/16" = 1'-0"

DATE

01/09/22

DRAWN

DK

SHEET NO

A100